



1 Main Site North South Section A-A
1 : 500

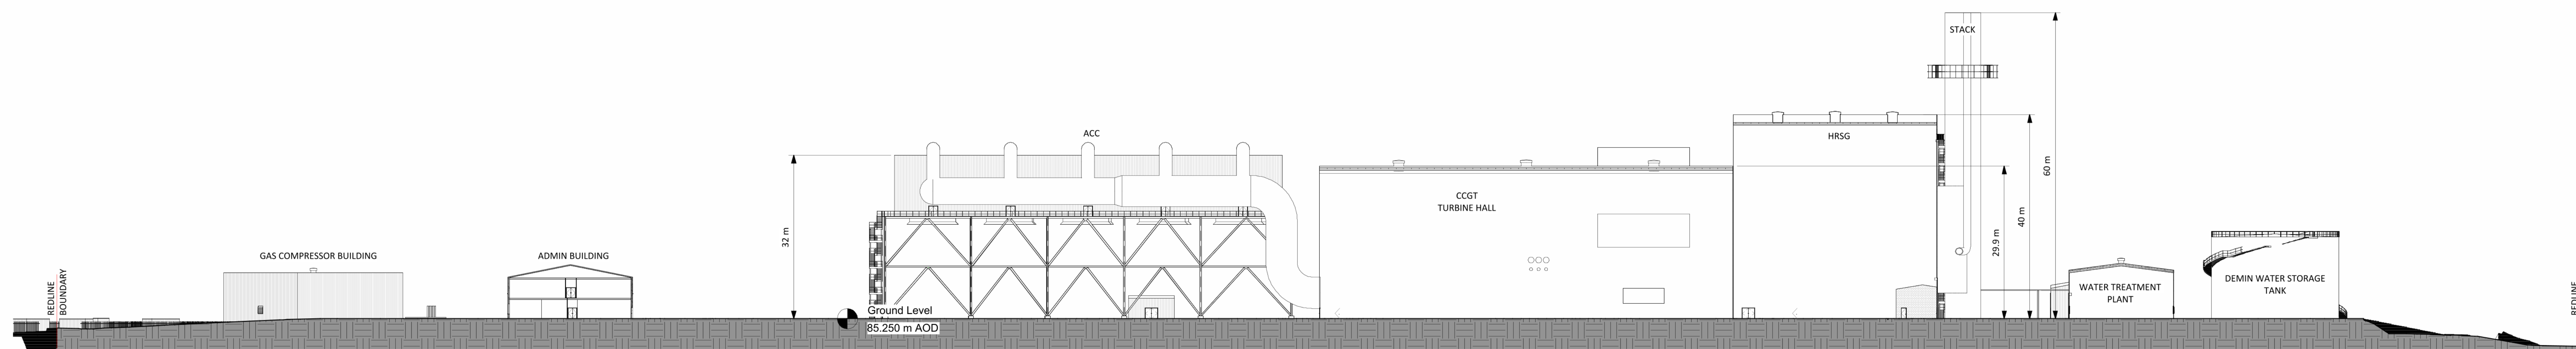

2 Main Site East West Section B-B
1 : 500

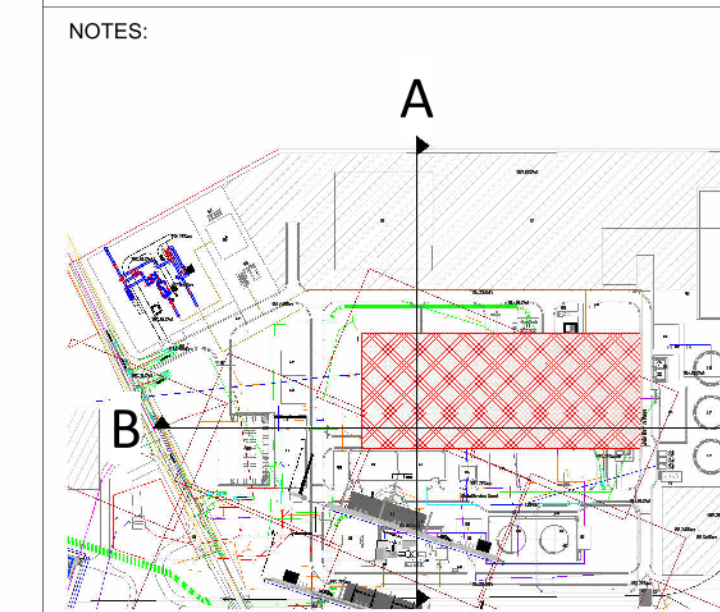

Key Plan
1 : 6000

- Building colours will range within a muted mid-dark grey and green spectrum. Refer to EIA Vol. II, Appendix 10A for detail
- Final detail of building finishes to be agreed with planning authority in advance of development commencing

R1.0 FOR PLANNING	DTW	A01	BAB	26.01.24
REV. DETAILS OF REVISION	DRAWN/CHKD	APR	DATE	

FICHTNER
CONSULTING ENGINEERS LIMITED
92 George's Street Lower
Dun Laoghaire
Co. Dublin, A98 V9R6
Tel: +353 (1) 508 0632
Website: www.fichtner.ie

CLIENT: Bord na Móna Powergen Limited

SITE:

PROJECT: Derrygreenagh Power

TITLE:


POWER PLANT AREA - MAIN SITE SECTIONS

DRAWING STATUS: For Planning	DATE: 26.01.24
DRAWN BY: DTW	DATE: 26.01.24
CHECKED BY: A01	DATE: 26.01.24
APPROVED BY: BAB	DATE: 26.01.24
FILENAME:	

OFFICE OF ISSUE: DUBLIN

DRAWING No.: S7060-8050-0037

REVISION:

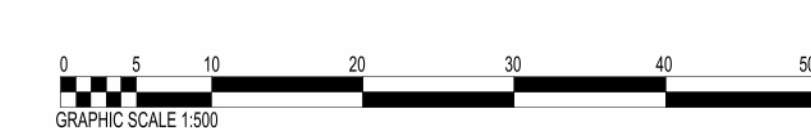

R1.0