
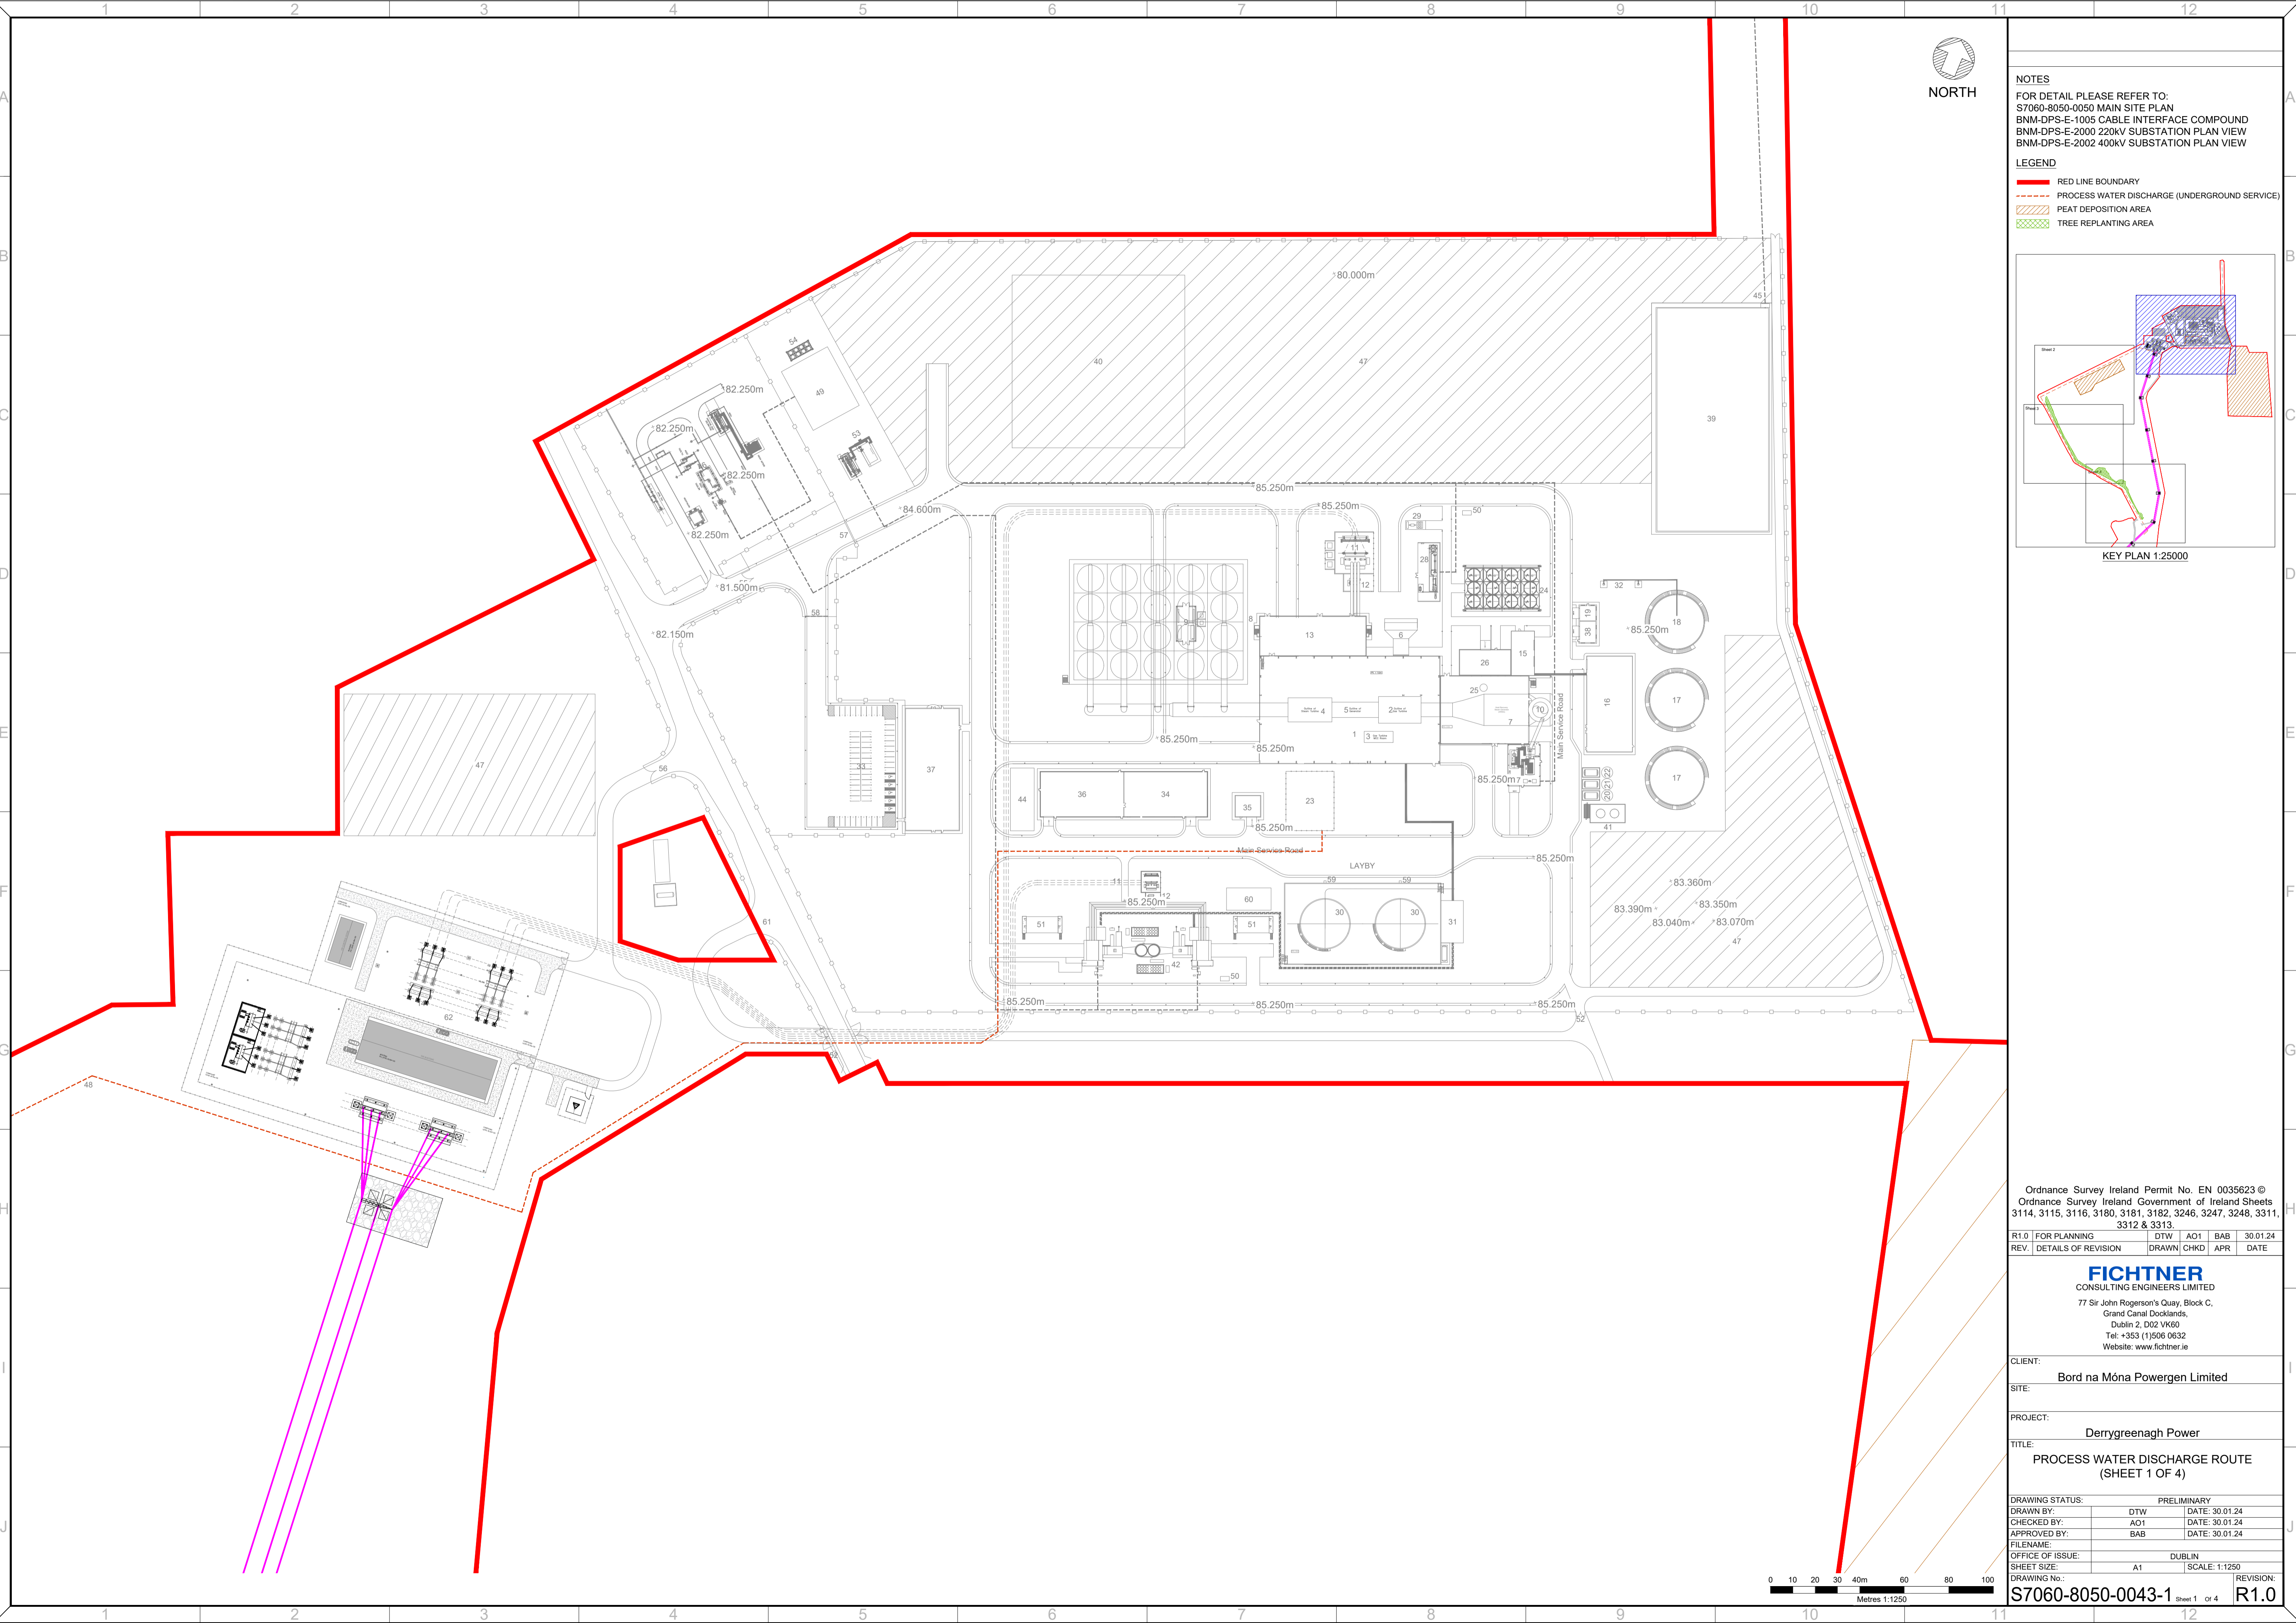


**NOTES**  
 FOR DETAIL PLEASE REFER TO:  
 S7060-8050-0050 MAIN SITE PLAN  
 BNM-DPS-E-1005 CABLE INTERFACE COMPOUND  
 BNM-DPS-E-2000 220KV SUBSTATION PLAN VIEW  
 BNM-DPS-E-2002 400KV SUBSTATION PLAN VIEW

- LEGEND**
- RED LINE BOUNDARY
  - - - - - PROCESS WATER DISCHARGE (UNDERGROUND SERVICE)
  - PEAT DEPOSITION AREA
  - TREE REPLANTING AREA

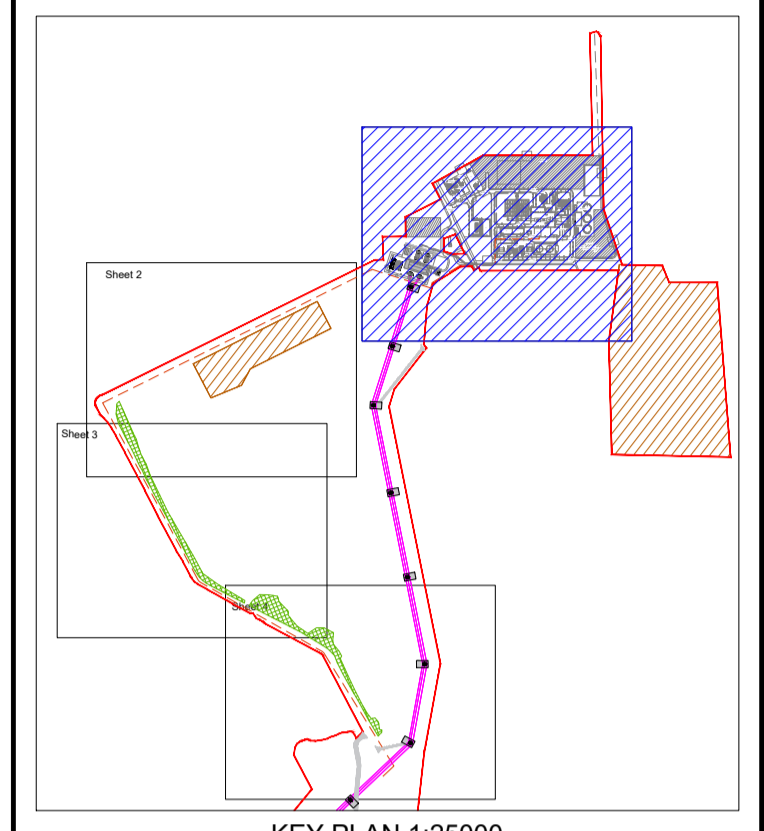

Ordnance Survey Ireland Permit No. EN 0035623 ©  
 Ordnance Survey Ireland Government of Ireland Sheets  
 3114, 3115, 3116, 3180, 3181, 3182, 3246, 3247, 3248, 3311,  
 3312 & 3313.

R1.0	FOR PLANNING	DTW	AO1	BAB	30.01.24
REV.	DETAILS OF REVISION	DRAWN	CHKD	APR	DATE

**FICHTNER**  
 CONSULTING ENGINEERS LIMITED  
 77 Sir John Rogerson's Quay, Block C,  
 Grand Canal Docklands,  
 Dublin 2, D02 VK60  
 Tel: +353 (1) 506 0632  
 Website: www.fichtner.ie

CLIENT: **Bord na Móna Powergen Limited**

SITE:

PROJECT: **Derrygreenagh Power**

TITLE: **PROCESS WATER DISCHARGE ROUTE (SHEET 1 OF 4)**

DRAWING STATUS:	PRELIMINARY	
DRAWN BY:	DTW	DATE: 30.01.24
CHECKED BY:	AO1	DATE: 30.01.24
APPROVED BY:	BAB	DATE: 30.01.24

OFFICE OF ISSUE: **DUBLIN**

SHEET SIZE: **A1** SCALE: 1:1250


DRAWING No.: **S7060-8050-0043-1** Sheet 1 of 4 REVISION: **R1.0**

ALL INFORMATION ON THIS DRAWING IS INDICATIVE ONLY,  
AND MAY BE SUBJECT TO  
FURTHER DESIGN DEVELOPMENT.




**NOTES**  
FOR DETAIL PLEASE REFER TO:  
S7060-8050-0050 MAIN SITE PLAN  
BNM-DPS-E-1005 CABLE INTERFACE COMPOUND  
BNM-DPS-E-2000 220KV SUBSTATION PLAN VIEW  
BNM-DPS-E-2002 400KV SUBSTATION PLAN VIEW

- LEGEND**
- RED LINE BOUNDARY
  - PROCESS WATER DISCHARGE (UNDERGROUND SERVICE)
  - PEAT DEPOSITION AREA
  - TREE REPLANTING AREA

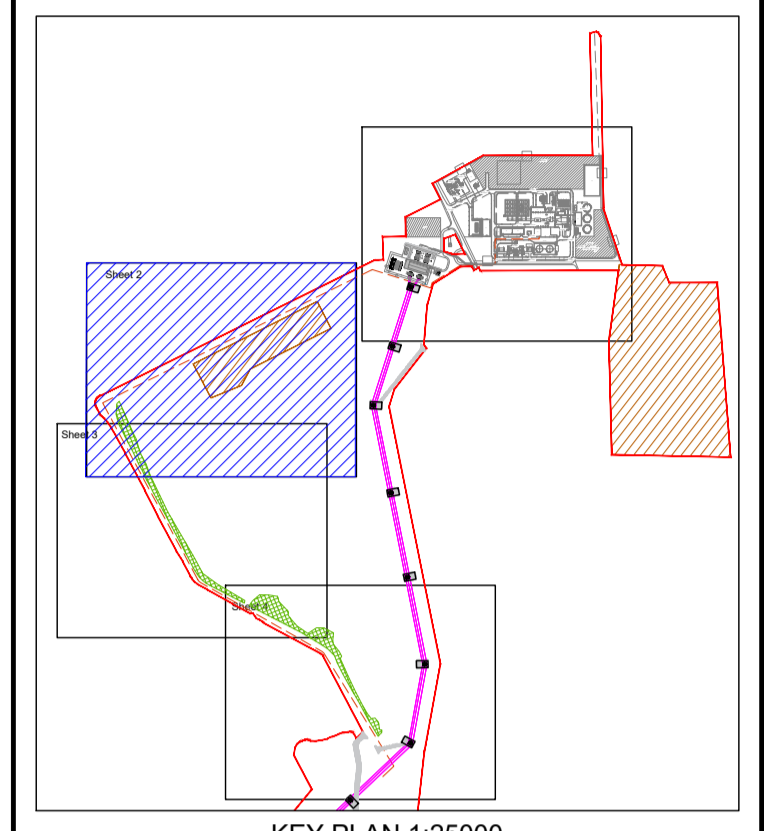

KEY PLAN 1:25000

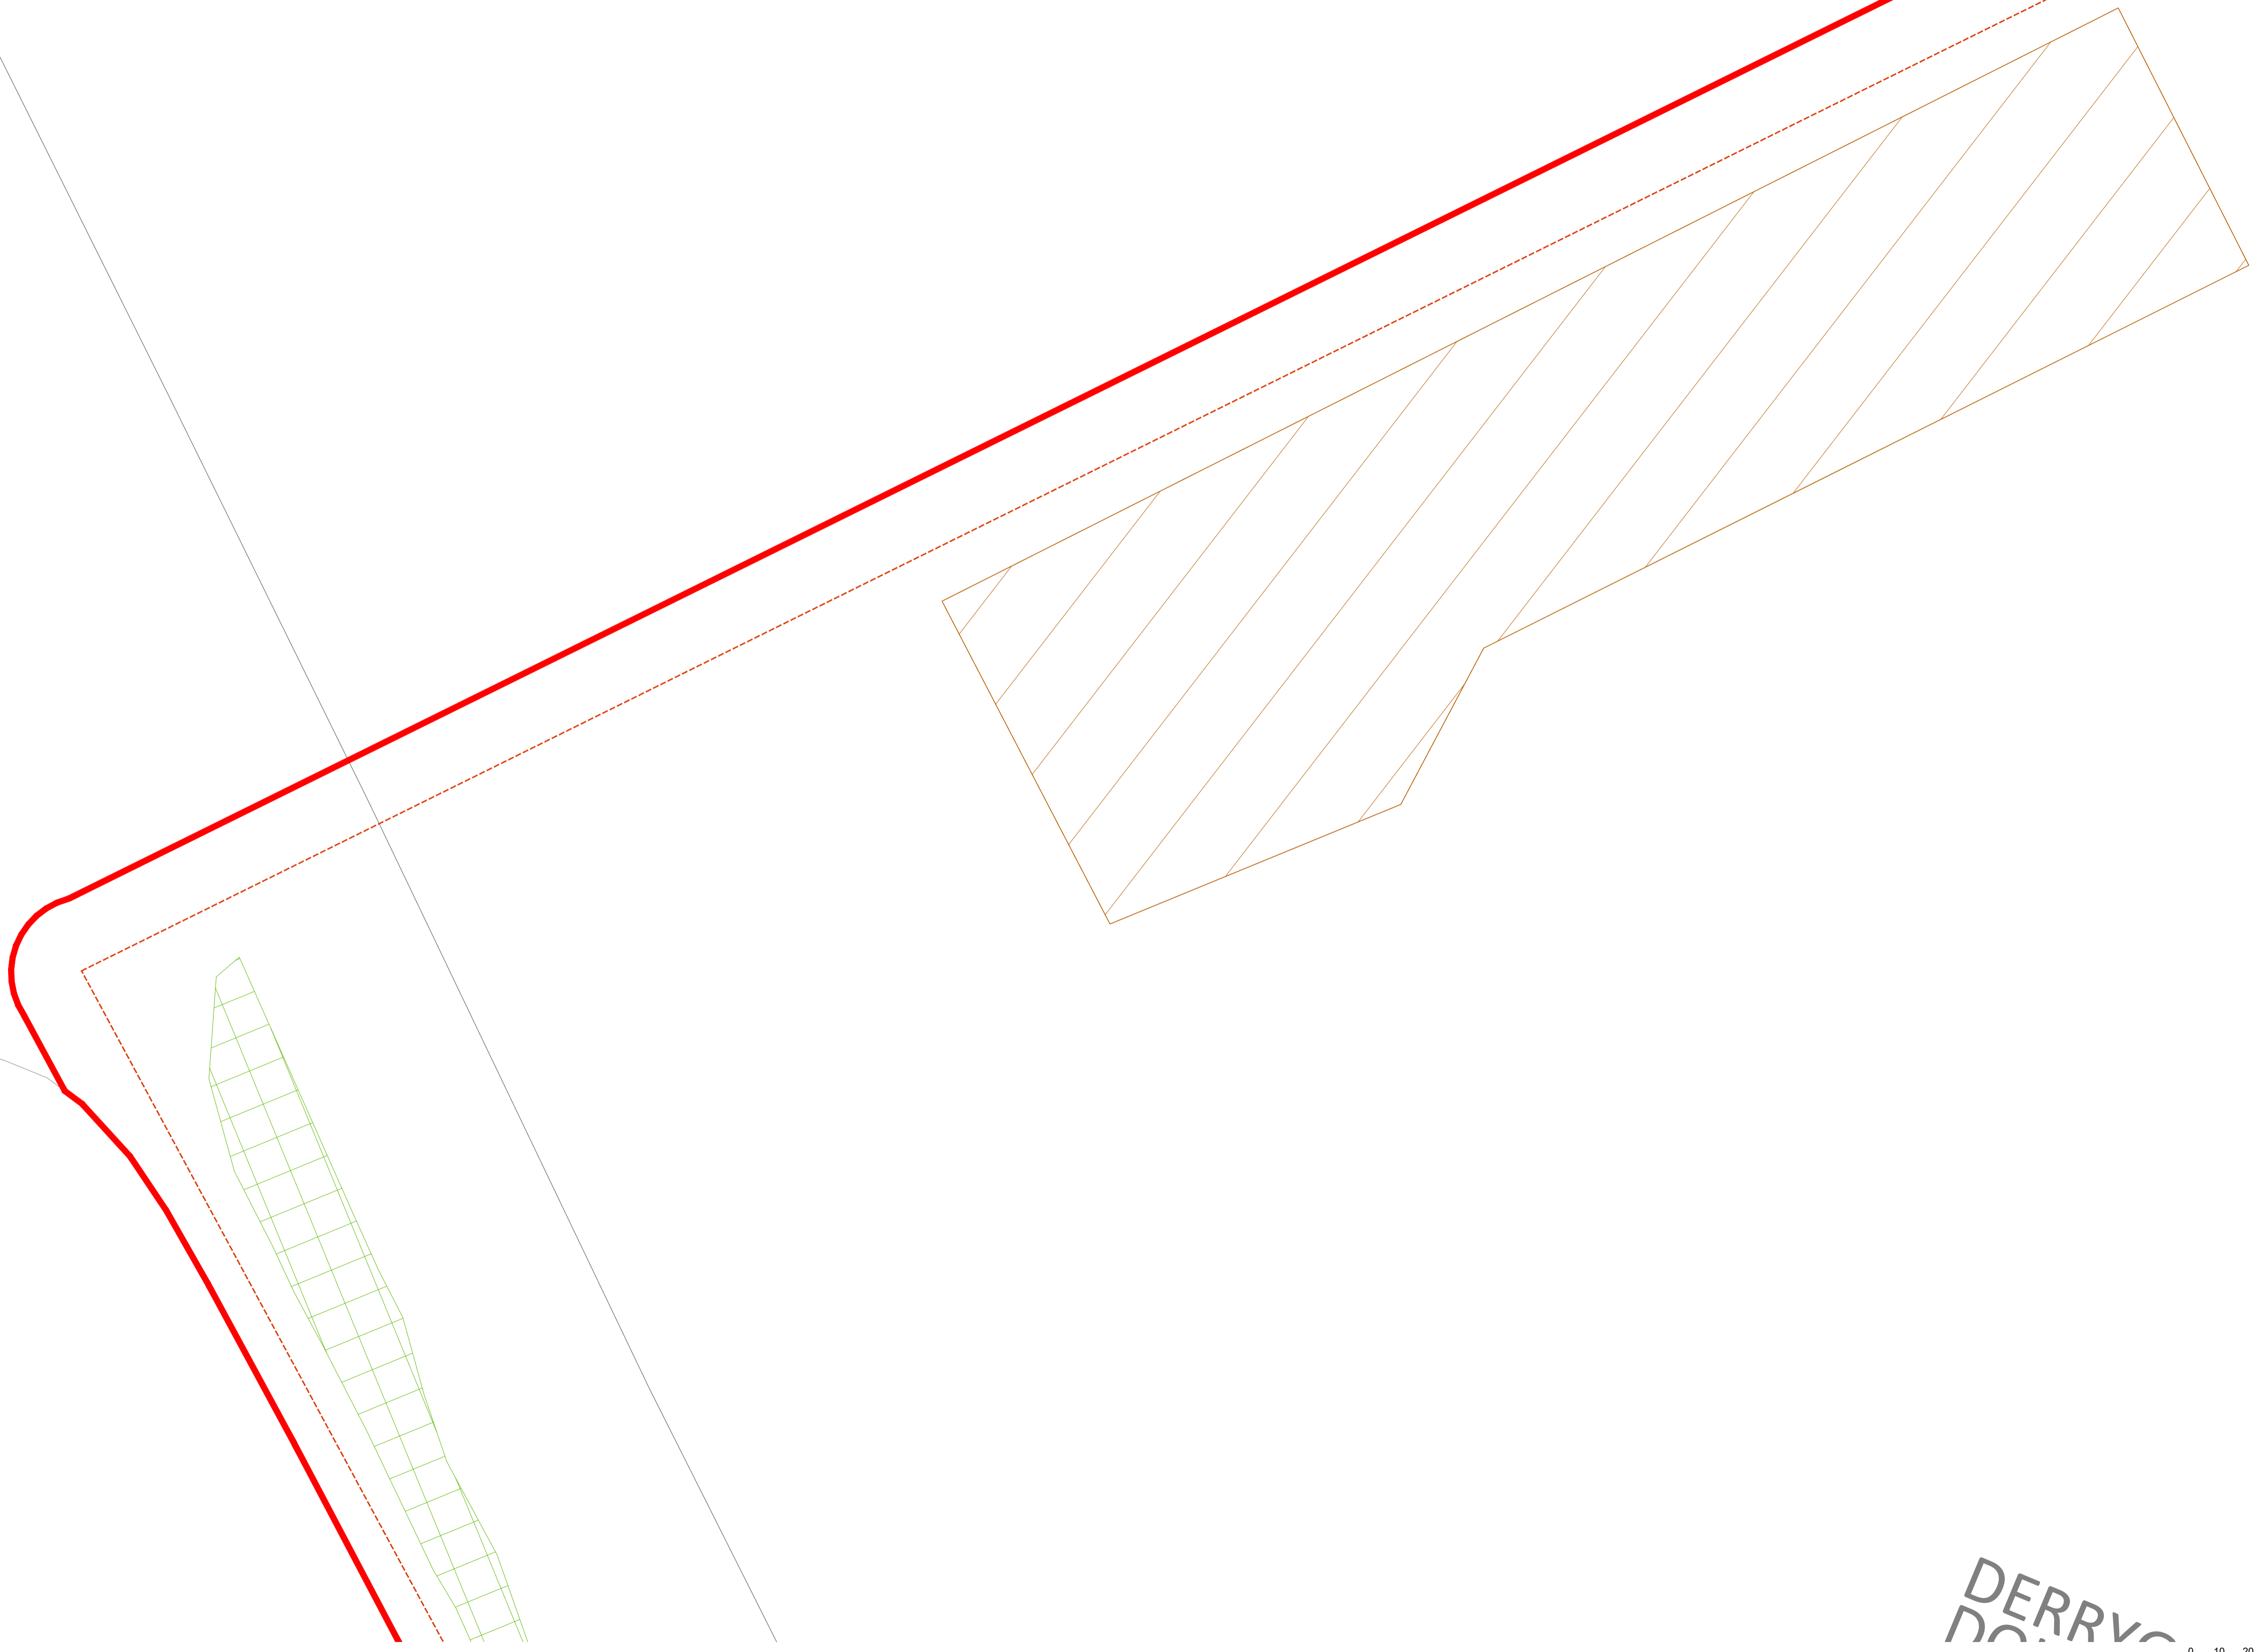

Ordnance Survey Ireland Permit No. EN 0035623 ©  
Ordnance Survey Ireland Government of Ireland Sheets  
3114, 3115, 3116, 3180, 3181, 3182, 3246, 3247, 3248, 3311,  
3312 & 3313.

R1.0	FOR PLANNING	DTW	DTW	BAB	30.01.24
REV.	DETAILS OF REVISION	DRAWN	CHKD	APR	DATE

**FICHTNER**  
CONSULTING ENGINEERS LIMITED  
77 Sir John Rogerson's Quay, Block C,  
Grand Canal Docklands,  
Dublin 2, D02 VK60  
Tel: +353 (1) 506 0632  
Website: www.fichtner.ie

CLIENT: **Bord na Móna Powergen Limited**

PROJECT: **Derrygreenagh Power**


TITLE: **PROCESS WATER DISCHARGE ROUTE  
(SHEET 2 OF 4)**

DRAWING STATUS:	PRELIMINARY	
DRAWN BY:	DTW	DATE: 30.01.24
CHECKED BY:	AO1	DATE: 30.01.24
APPROVED BY:	BAB	DATE: 30.01.24

OFFICE OF ISSUE: **DUBLIN**

SHEET SIZE: **A1** SCALE: 1:1250  
DRAWING No.: **S7060-8050-0043-2** Sheet 2 of 4 REVISION: **R1.0**

**DERRYGREENAGH**

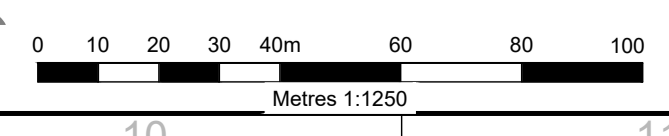


ALL INFORMATION ON THIS DRAWING IS INDICATIVE ONLY.  
AND MAY BE SUBJECT TO  
FURTHER DESIGN DEVELOPMENT.



**NOTES**  
FOR DETAIL PLEASE REFER TO:  
S7060-8050-0050 MAIN SITE PLAN  
BNM-DPS-E-1005 CABLE INTERFACE COMPOUND  
BNM-DPS-E-2000 220kV SUBSTATION PLAN VIEW  
BNM-DPS-E-2002 400kV SUBSTATION PLAN VIEW

**LEGEND**  
— RED LINE BOUNDARY  
- - - PROCESS WATER DISCHARGE (UNDERGROUND SERVICE)  
▨ PEAT DEPOSITION AREA  
▧ TREE REPLANTING AREA

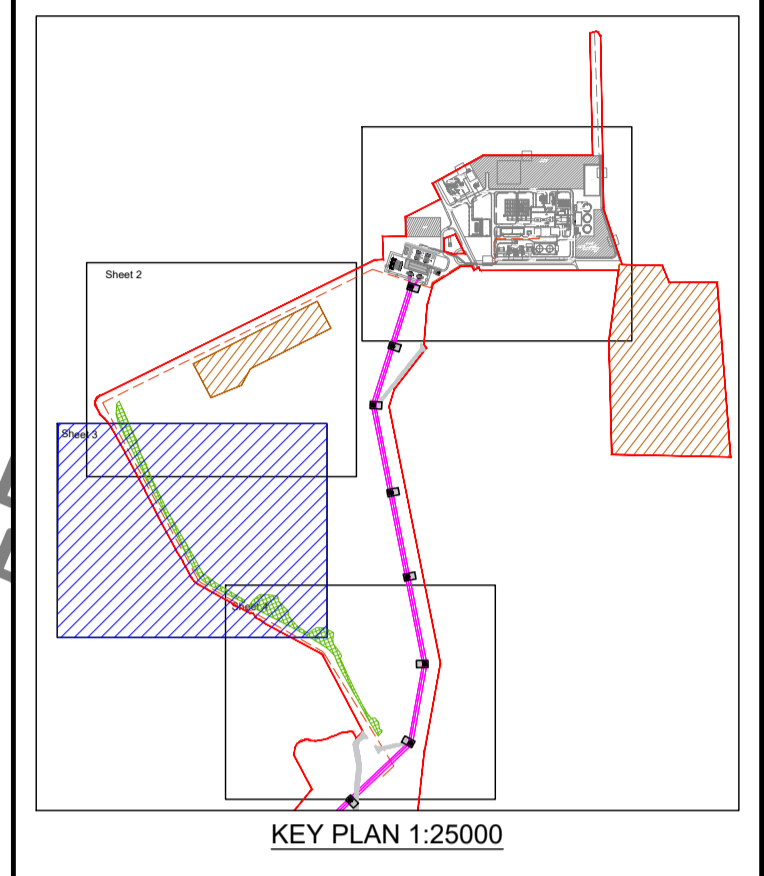

DERRYGR  
DOIRE DHI



Ordnance Survey Ireland Permit No. EN 0035623 ©  
Ordnance Survey Ireland Government of Ireland Sheets  
3114, 3115, 3116, 3180, 3181, 3182, 3246, 3247, 3248, 3311,  
3312 & 3313.


R1.0	FOR PLANNING	DTW	AO1	BAB	30.01.24
REV.	DETAILS OF REVISION	DRAWN	CHKD	APR	DATE

**FICHTNER**  
CONSULTING ENGINEERS LIMITED  
77 Sir John Rogerson's Quay, Block C,  
Grand Canal Docklands,  
Dublin 2, D02 VK60  
Tel: +353 (1) 506 0632  
Website: www.fichtner.ie

CLIENT: **Bord na Móna Powergen Limited**  
SITE:  
PROJECT: **Derrygreenagh Power**  
TITLE: **PROCESS WATER DISCHARGE ROUTE  
(SHEET 3 OF 4)**

DRAWING STATUS: PRELIMINARY	
DRAWN BY: DTW	DATE: 30.01.24
CHECKED BY: AO1	DATE: 30.01.24
APPROVED BY: BAB	DATE: 30.01.24
FILENAME:	
OFFICE OF ISSUE: DUBLIN	
SHEET SIZE: A1	SCALE: 1:1250
DRAWING No.:	REVISION:

**S7060-8050-0043-3** Sheet 3 of 4 **R1.0**


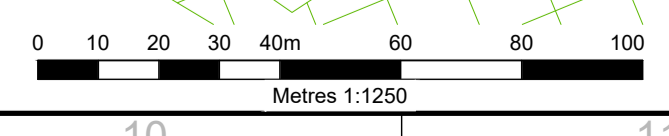


ALL INFORMATION ON THIS DRAWING IS INDICATIVE ONLY,  
AND MAY BE SUBJECT TO  
FURTHER DESIGN DEVELOPMENT.



**NOTES**  
FOR DETAIL PLEASE REFER TO:  
S7060-8050-0050 MAIN SITE PLAN  
BNM-DPS-E-1005 CABLE INTERFACE COMPOUND  
BNM-DPS-E-2000 220kV SUBSTATION PLAN VIEW  
BNM-DPS-E-2002 400kV SUBSTATION PLAN VIEW

**LEGEND**  
 RED LINE BOUNDARY  
 PROCESS WATER DISCHARGE (UNDERGROUND SERVICE)  
 PEAT DEPOSITION AREA  
 TREE REPLANTING AREA

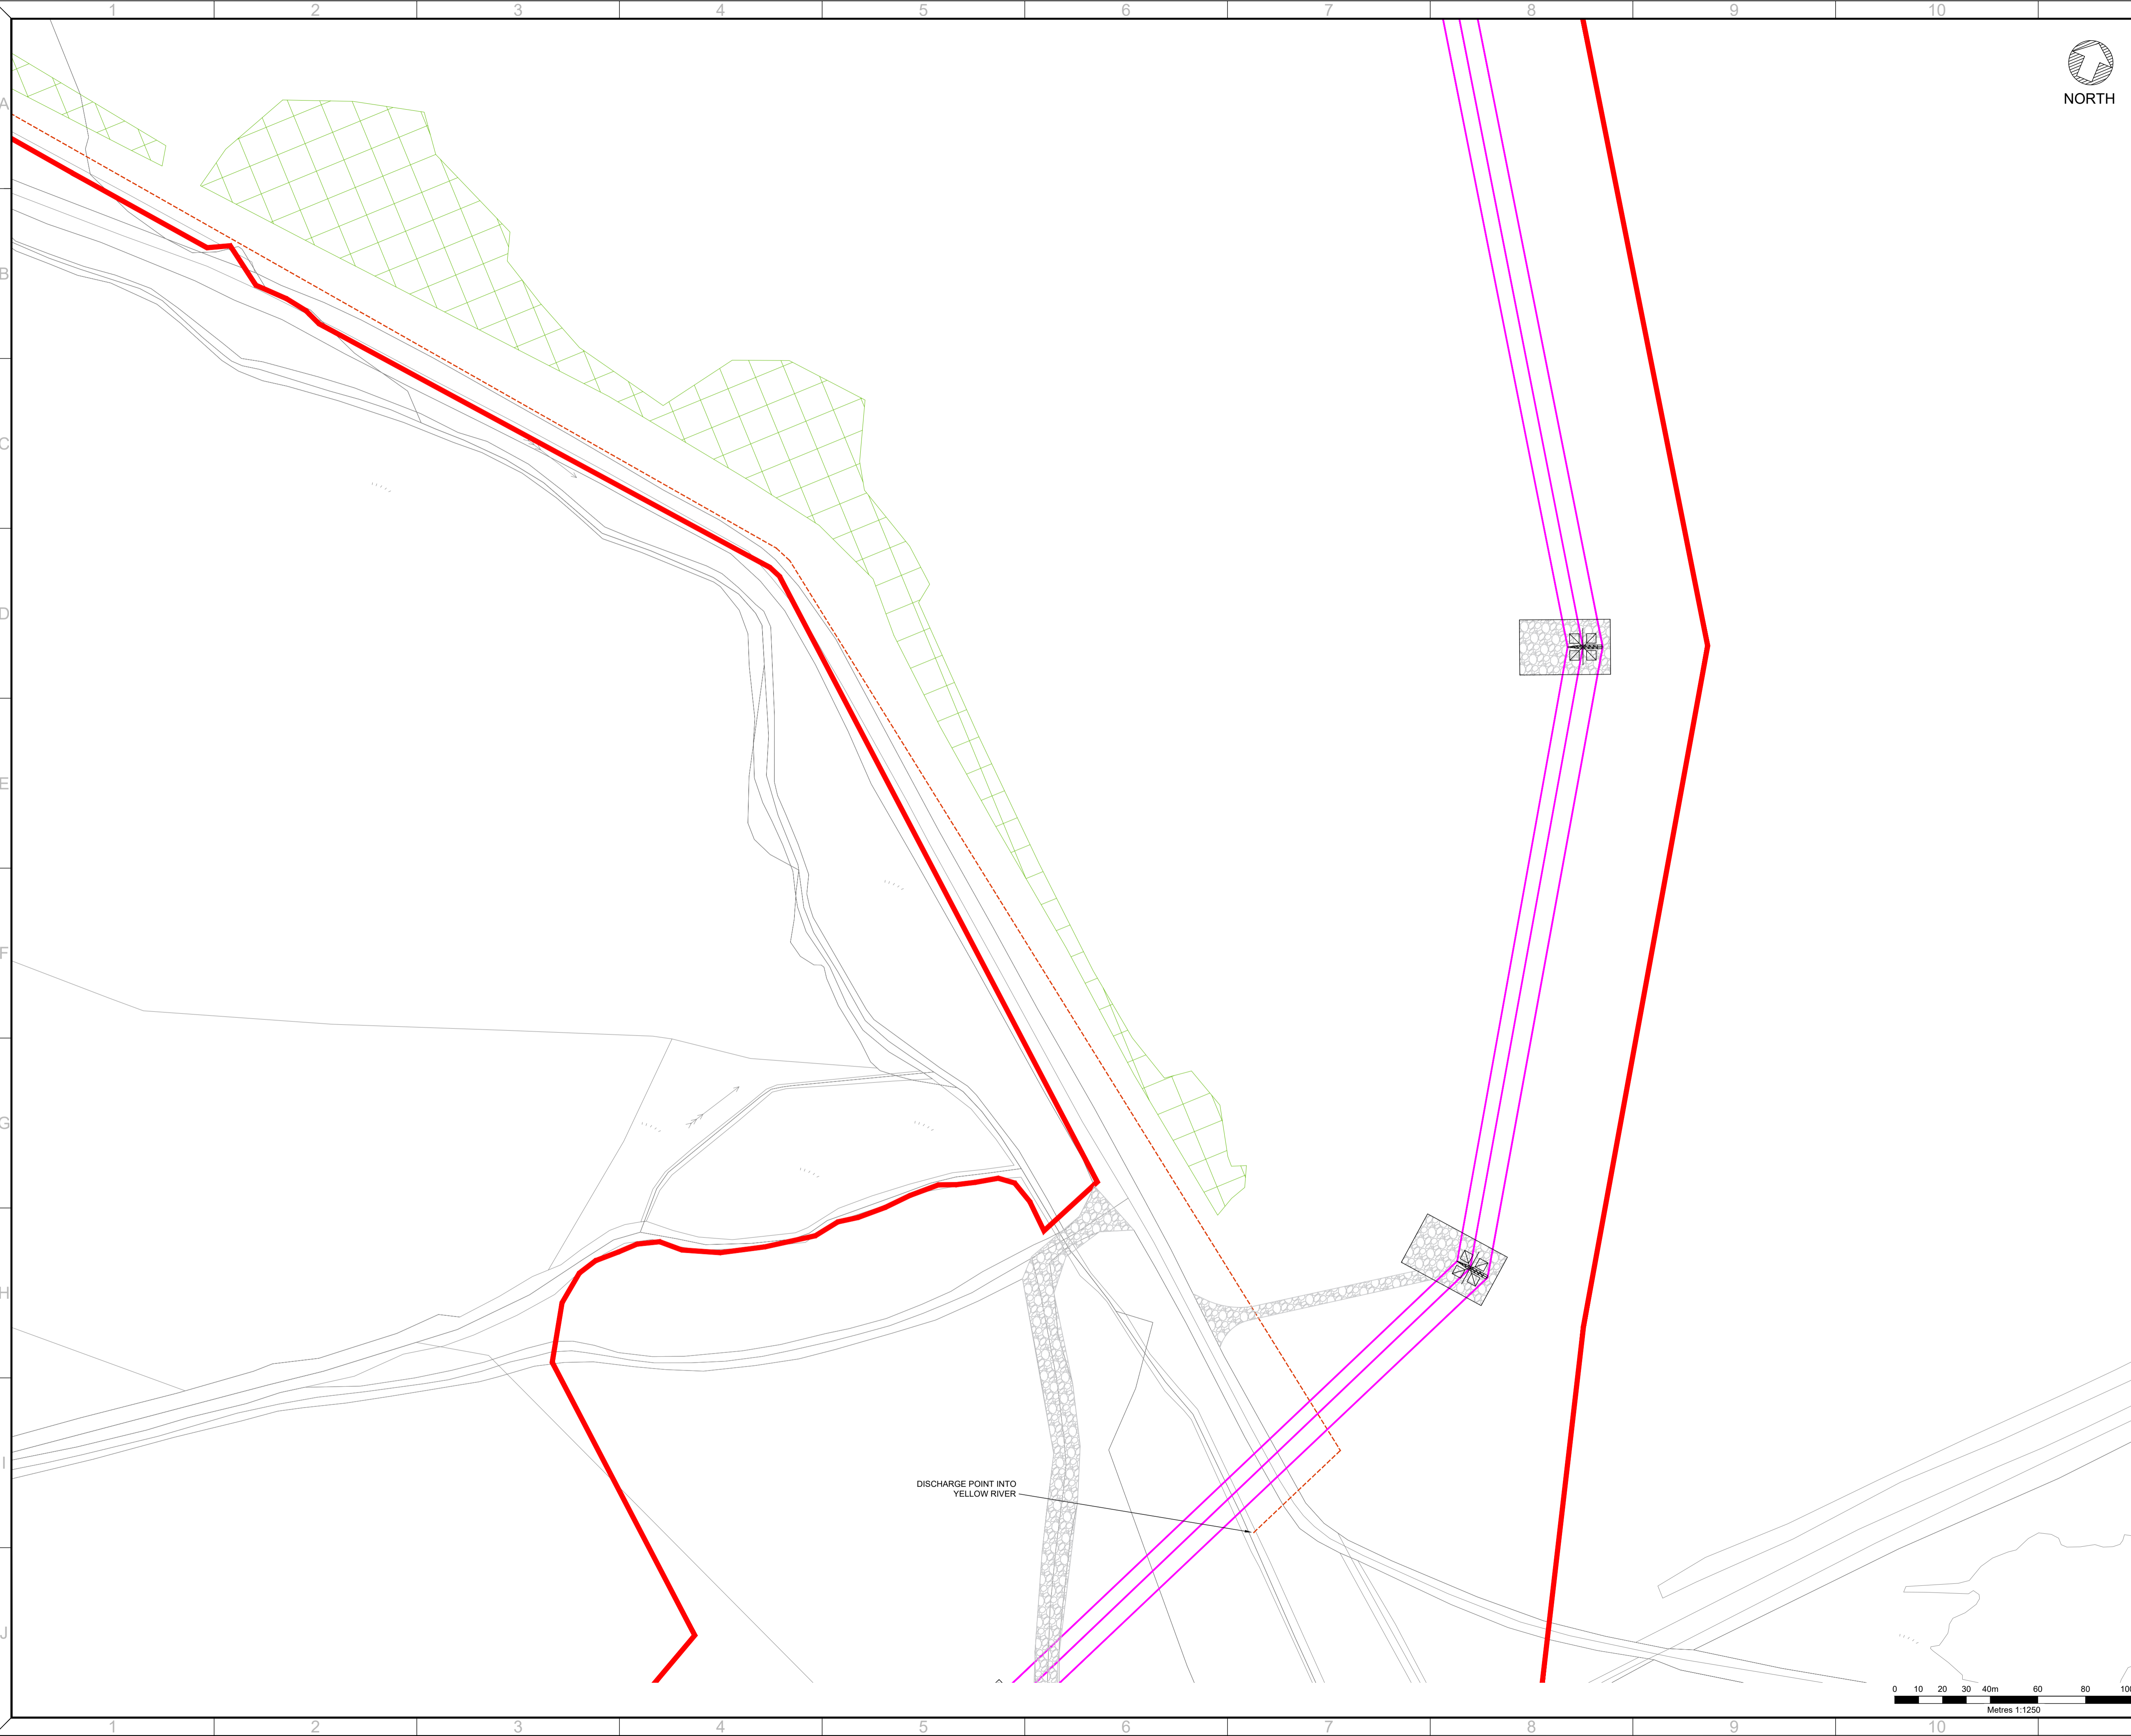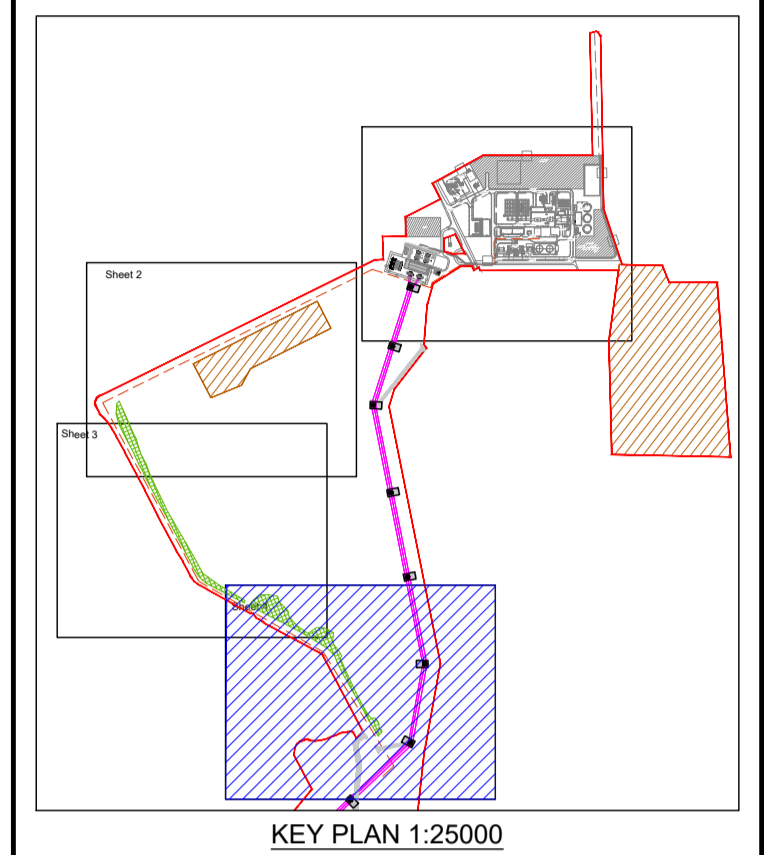

DISCHARGE POINT INTO  
YELLOW RIVER

Ordnance Survey Ireland Permit No. EN 0035623 ©  
Ordnance Survey Ireland Government of Ireland Sheets  
3114, 3115, 3116, 3180, 3181, 3182, 3246, 3247, 3248, 3311,  
3312 & 3313.

R1.0	FOR PLANNING	DTW	AO1	BAB	30.01.24
REV.	DETAILS OF REVISION	DRAWN	CHKD	APR	DATE

**FICHTNER**  
CONSULTING ENGINEERS LIMITED  
77 Sir John Rogerson's Quay, Block C,  
Grand Canal Docklands,  
Dublin 2, D02 VK60  
Tel: +353 (1) 506 0632  
Website: www.fichtner.ie


CLIENT:  
**Bord na Móna Powergen Limited**

PROJECT:  
**Derrygreenagh Power**

TITLE:  
**PROCESS WATER DISCHARGE ROUTE  
(SHEET 4 OF 4)**

DRAWING STATUS:	PRELIMINARY	
DRAWN BY:	DTW	DATE: 30.01.24
CHECKED BY:	AO1	DATE: 30.01.24
APPROVED BY:	BAB	DATE: 30.01.24

OFFICE OF ISSUE: DUBLIN  
SHEET SIZE: A1 SCALE: 1:1250

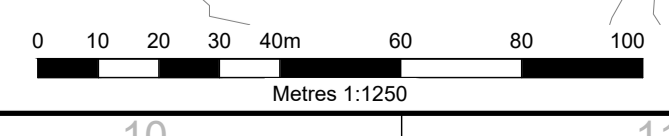

DRAWING No.: **S7060-8050-0043-4** Sheet 4 of 4 REVISION: **R1.0**